

Sec-142 C Entry Exit


NOTES:

- FOR CUTOUT/SLEEVES IN RCC, REFER STRUCTURE DRAWING
- FOR CUTOUT/SLEEVES IN BRICK WORK REFER WALL OPENING DRAWINGS
- FOR SLEEVES/CUTOUTS IN LIFT AND ESCALATOR PITS REFER VENDOR DRAWINGS
- FOR RAILING/FINISH DETAILS REFER NGN-DTD-AR-TYPL-1972

■ - VENDING MACHINE (0 To 5 sqm)

■ - KIOSK (5 To 10 sqm)

ALL DIMENSION IN METER

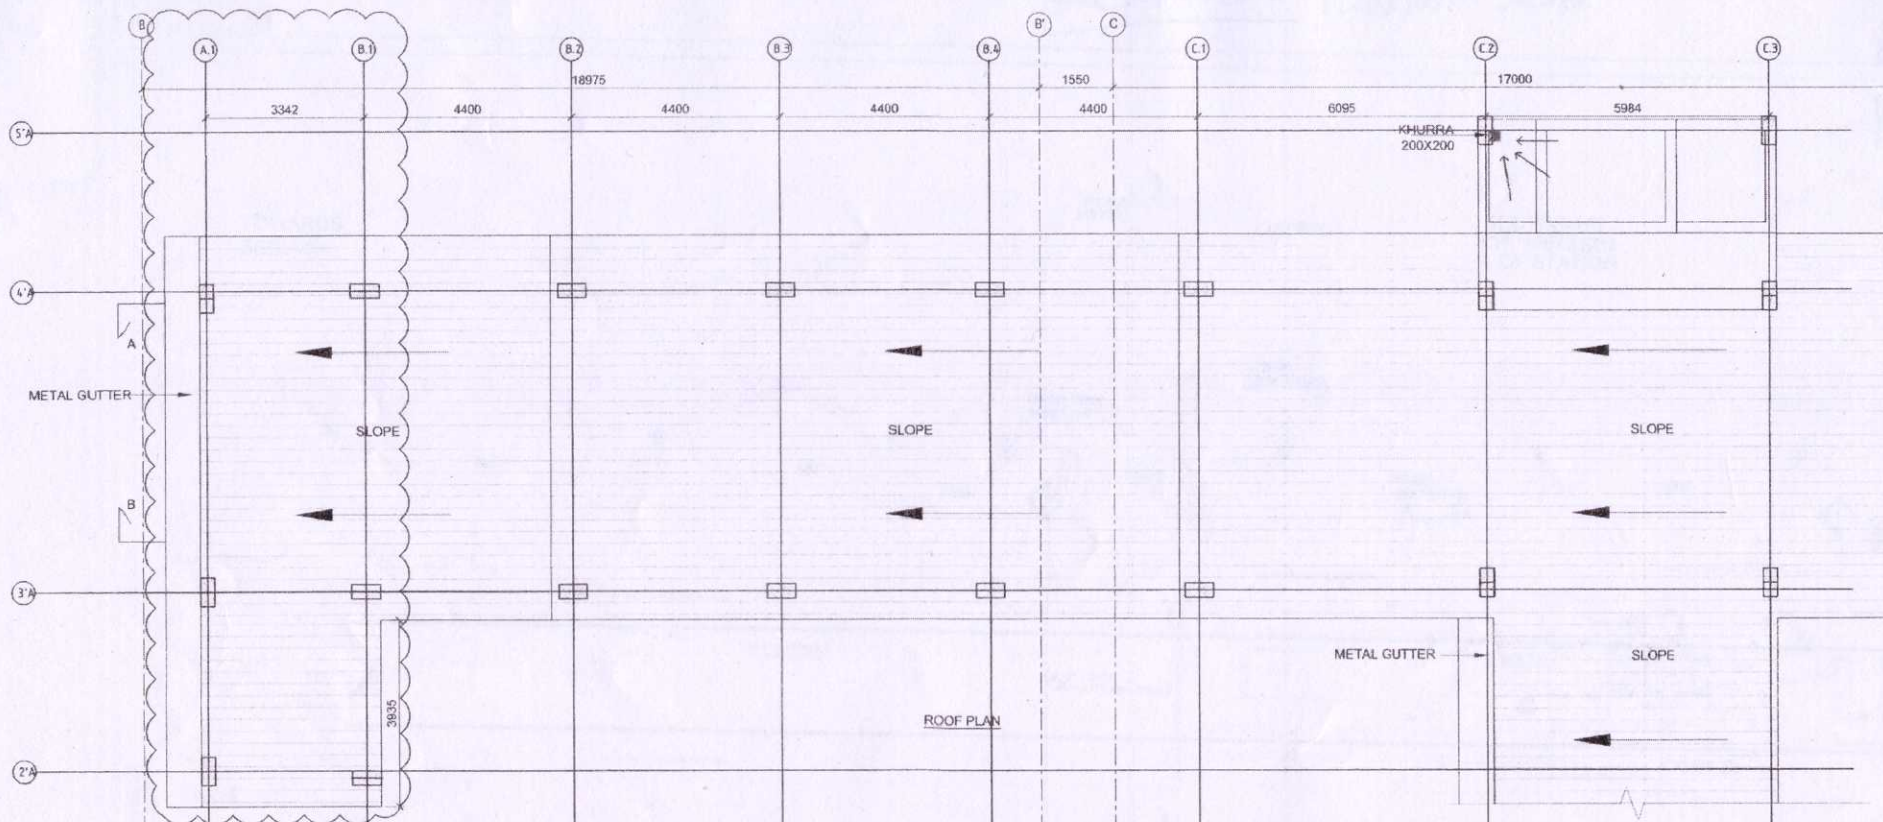


AS-BUILT DRAWING			
DDC REPRESENTATIVE			
Company Name	Designation	Name	Signature
AYESA	Project Manager	P. Banerjee	[Signature]
CONTRACTOR'S REPRESENTATIVE			
Company Name	Designation	Name	Signature
ETC-SAM INDIA	Project Director	Himanshu Kumar	[Signature]
DMRC REPRESENTATIVE			
Company Name	Designation	Name	Signature
DMRC	JRE	DEEPAK	[Signature]
DMRC	RE	V. V. REDDY	[Signature]
DMRC	CRE/ORE	C. P. SINGH	[Signature]

Handwritten notes: *Handwritten signature*, *DMRC/ini*

TOTAL V.M. — 0

TOTAL KIOSK — 3

May kindly also look into provision of fire & safety clearance.
O.K. work ARE TEL 03/12/24

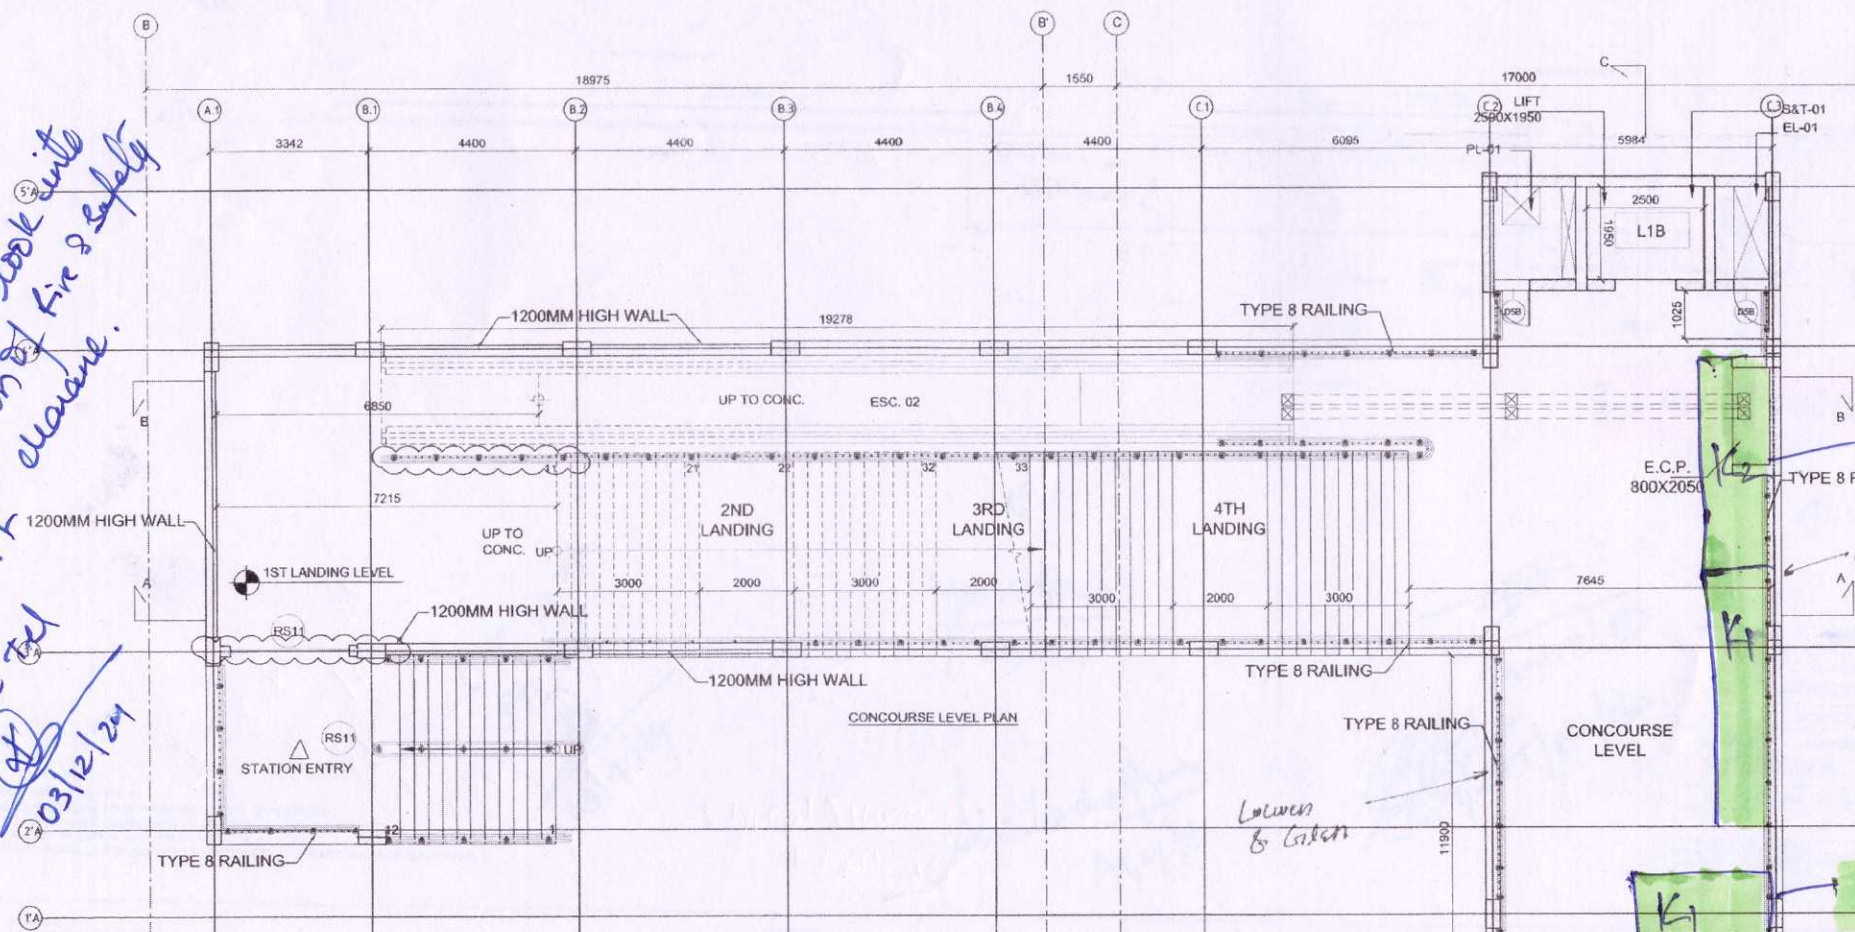

DOOR SCHEDULE		
S.No	Width	Height
D3B	1050	2105
D5B	750	2005
RS06	2500	3000
RS07	2000	3000
RS11	3000	3000

Level	F.F.L
Concourse	205.62
4th Landing	203.97
3rd Landing	202.32
2nd Landing	200.67
1st Landing	199.02
Lift Lobby	197.97
Platform	197.28
Ground Level	197.13
Pump Room Level	193.62
Water Tank Level	194.07

SCHEDULE OF CUTOUTS/SHAFTS			
S.No	Purpose	Size (mm)	Location
PL-01	Plumbing & Fire Fighting Cutout	800X800	Concourse
PL-05	Sump Cutout	750X600	Pump Room
PL-06	Sump Cutout	600X600	Pump Room
HV-01	Exhaust Air Ventilation Cutout	900X500	Ground
HV-02	Fresh Air Ventilation Cutout	900X500	Ground
EL-01	Electrical Cutout	1950X750	Concourse
EL-03	Electrical Cutout	450X600	Ground
S&T-01	Signalling & Telecom Cutout	1950X300	Concourse

Sec-142/C/Kiosk/572

Handwritten signature: *Shailendra Kumar*, *APM/E*

Sec-142/001/Kiosk/572

<p>GENERAL NOTE:</p> <p>1. ALL DIMENSIONS ARE IN MILLIMETER UNLESS MENTIONED.</p> <p>2. ALL DIMENSIONS ARE TO BE READ AND NOT MEASURED.</p> <p>3. ANY DISCREPANCY MUST BE BROUGHT TO THE NOTICE OF THE DMRC BEFORE EXECUTION OF WORK AT SITE.</p> <p>4. THE DRAWING MUST BE READ IN CONJUNCTION WITH ALL RELEVANT ARCHITECTURAL, STRUCTURAL, PLUMBING & FIRE FIGHTING, ELECTRICAL AND TYPING MANAGEMENT DRAWINGS.</p> <p>5. ALL DIMENSIONS FROM CELL & LIFT LEVEL UNLESS SPECIFIED FROM MAIN FLOOR FINISHED LEVELS.</p>	<p>REVISIONS</p> <table border="1"> <thead> <tr> <th>REV.</th> <th>DESCRIPTION</th> <th>DATE</th> <th>DRAWN BY</th> <th>CHECKED BY</th> </tr> </thead> <tbody> <tr> <td>R2</td> <td>COMMENTS INCORPORATED AS PER THE INFORMATION RECEIVED BY THE CONTRACTOR DATED ON 09.04.18</td> <td>11.04.18</td> <td>MANISHA</td> <td>SHAFALI</td> </tr> <tr> <td>R1</td> <td>COMMENTS INCORPORATED AS PER THE INFORMATION RECEIVED BY THE CONTRACTOR DATED ON 09.03.18</td> <td>16.03.18</td> <td>MANISHA</td> <td>SHAFALI</td> </tr> </tbody> </table>				REV.	DESCRIPTION	DATE	DRAWN BY	CHECKED BY	R2	COMMENTS INCORPORATED AS PER THE INFORMATION RECEIVED BY THE CONTRACTOR DATED ON 09.04.18	11.04.18	MANISHA	SHAFALI	R1	COMMENTS INCORPORATED AS PER THE INFORMATION RECEIVED BY THE CONTRACTOR DATED ON 09.03.18	16.03.18	MANISHA	SHAFALI	<p>APPROVAL OF DMRC OFFICIALS</p> <table border="1"> <thead> <tr> <th>RA</th> <th>Dy CA/Arch</th> <th>CA</th> <th>AM/Trn</th> <th>Sr. DGM/Trn</th> <th>EDS&T/P-4</th> </tr> </thead> <tbody> <tr> <td>AM/Elct</td> <td>DCM/Inc</td> <td>CEE</td> <td>AM/Sig</td> <td>JGM/S&T-4</td> <td>ED/S&T/P-4</td> </tr> <tr> <td>AM/AF</td> <td>Dy CSTE/AF</td> <td>MNGR/FIRE</td> <td>CRE</td> <td>POH-GN</td> <td></td> </tr> </tbody> </table>				RA	Dy CA/Arch	CA	AM/Trn	Sr. DGM/Trn	EDS&T/P-4	AM/Elct	DCM/Inc	CEE	AM/Sig	JGM/S&T-4	ED/S&T/P-4	AM/AF	Dy CSTE/AF	MNGR/FIRE	CRE	POH-GN		<p>Authorized Signatory for DDC, NCCD01 Project Manager</p> <p>Confirmed that this document has been designed and checked in accordance with DDC Quality Assurance Plan.</p> <table border="1"> <thead> <tr> <th>Architecture</th> <th>Structure</th> <th>EAM</th> </tr> </thead> <tbody> <tr> <td>Shailendra Kumar Design In-charge/Coordinator</td> <td>[Signature] Design In-charge/Coordinator</td> <td>[Signature] Design In-charge/Coordinator</td> </tr> </tbody> </table>				Architecture	Structure	EAM	Shailendra Kumar Design In-charge/Coordinator	[Signature] Design In-charge/Coordinator	[Signature] Design In-charge/Coordinator
	REV.	DESCRIPTION	DATE	DRAWN BY	CHECKED BY																																														
R2	COMMENTS INCORPORATED AS PER THE INFORMATION RECEIVED BY THE CONTRACTOR DATED ON 09.04.18	11.04.18	MANISHA	SHAFALI																																															
R1	COMMENTS INCORPORATED AS PER THE INFORMATION RECEIVED BY THE CONTRACTOR DATED ON 09.03.18	16.03.18	MANISHA	SHAFALI																																															
RA	Dy CA/Arch	CA	AM/Trn	Sr. DGM/Trn	EDS&T/P-4																																														
AM/Elct	DCM/Inc	CEE	AM/Sig	JGM/S&T-4	ED/S&T/P-4																																														
AM/AF	Dy CSTE/AF	MNGR/FIRE	CRE	POH-GN																																															
Architecture	Structure	EAM																																																	
Shailendra Kumar Design In-charge/Coordinator	[Signature] Design In-charge/Coordinator	[Signature] Design In-charge/Coordinator																																																	
<p>REFERENCE DRAWINGS</p> <table border="1"> <thead> <tr> <th>REVISION</th> <th>DESCRIPTION</th> <th>DRAWING NO.</th> </tr> </thead> <tbody> <tr> <td></td> <td></td> <td></td> </tr> </tbody> </table>	REVISION	DESCRIPTION	DRAWING NO.				<p>ayesa Engineering, Information, Imagination.</p> <p>56, Indo-Asia House, Institutional Area, sector-44 Gurgaon - 122002 (Haryana)</p>																																												
REVISION	DESCRIPTION	DRAWING NO.																																																	

<p>DELHI METRO RAIL CORPORATION LTD.</p> <p>Metro Bhawan, Fire Bhdga Lane, Barakhamba Road, New Delhi-110001</p>			
<p>PROJECT: NOIDA - GREATER NOIDA CORRIDOR</p> <p>STATION: SECTOR-142</p>			
<p>DRAWING TITLE: ENTRY STRUCTURE - PLANS</p>			
<p>NORTH</p> <p>DRAWN BY: MNN</p> <p>DATE: 19.04.18</p>	<p>CHECKED BY: SML</p> <p>REV: R-2</p>	<p>VERIFIED BY: SML</p> <p>SCALE: 1:75</p>	<p>APPROVED BY: PMD</p> <p>STATUS: AS BUILT</p>
<p>ORDER NO: 1954/2012</p>	<p>DRAWING NUMBER: NGN-DTD-AR-99S142-1952</p>	<p>SHEET NO:</p>	<p>SHEET SIZE: A-1</p>